

Revisions		
No.	Date	Description


HUGHES ASSOCIATES
ARCHITECTS & ENGINEERS
 656 ELM AVENUE, S.W. | ROANOKE, VIRGINIA 24005-1034
 540.342.4002
 www.hughesaE.com

New Addition For
New River Electrical
 15 Cloverdale Pl. Cloverdale, Virginia


DRAWN BY: RGM
 CHECKED BY: JMM

PARTIAL FLOOR PLANS
 -MECHANICAL


MANN & ASSOCIATES, INC.
 306 Market Street
 Roanoke, VA 24011
 540-344-5515

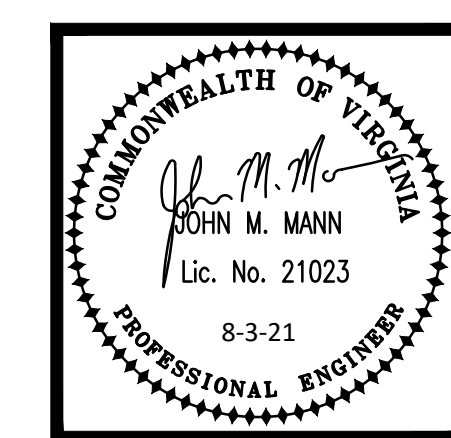

COMMISSION No.
 20064
 SHEET
M1-1

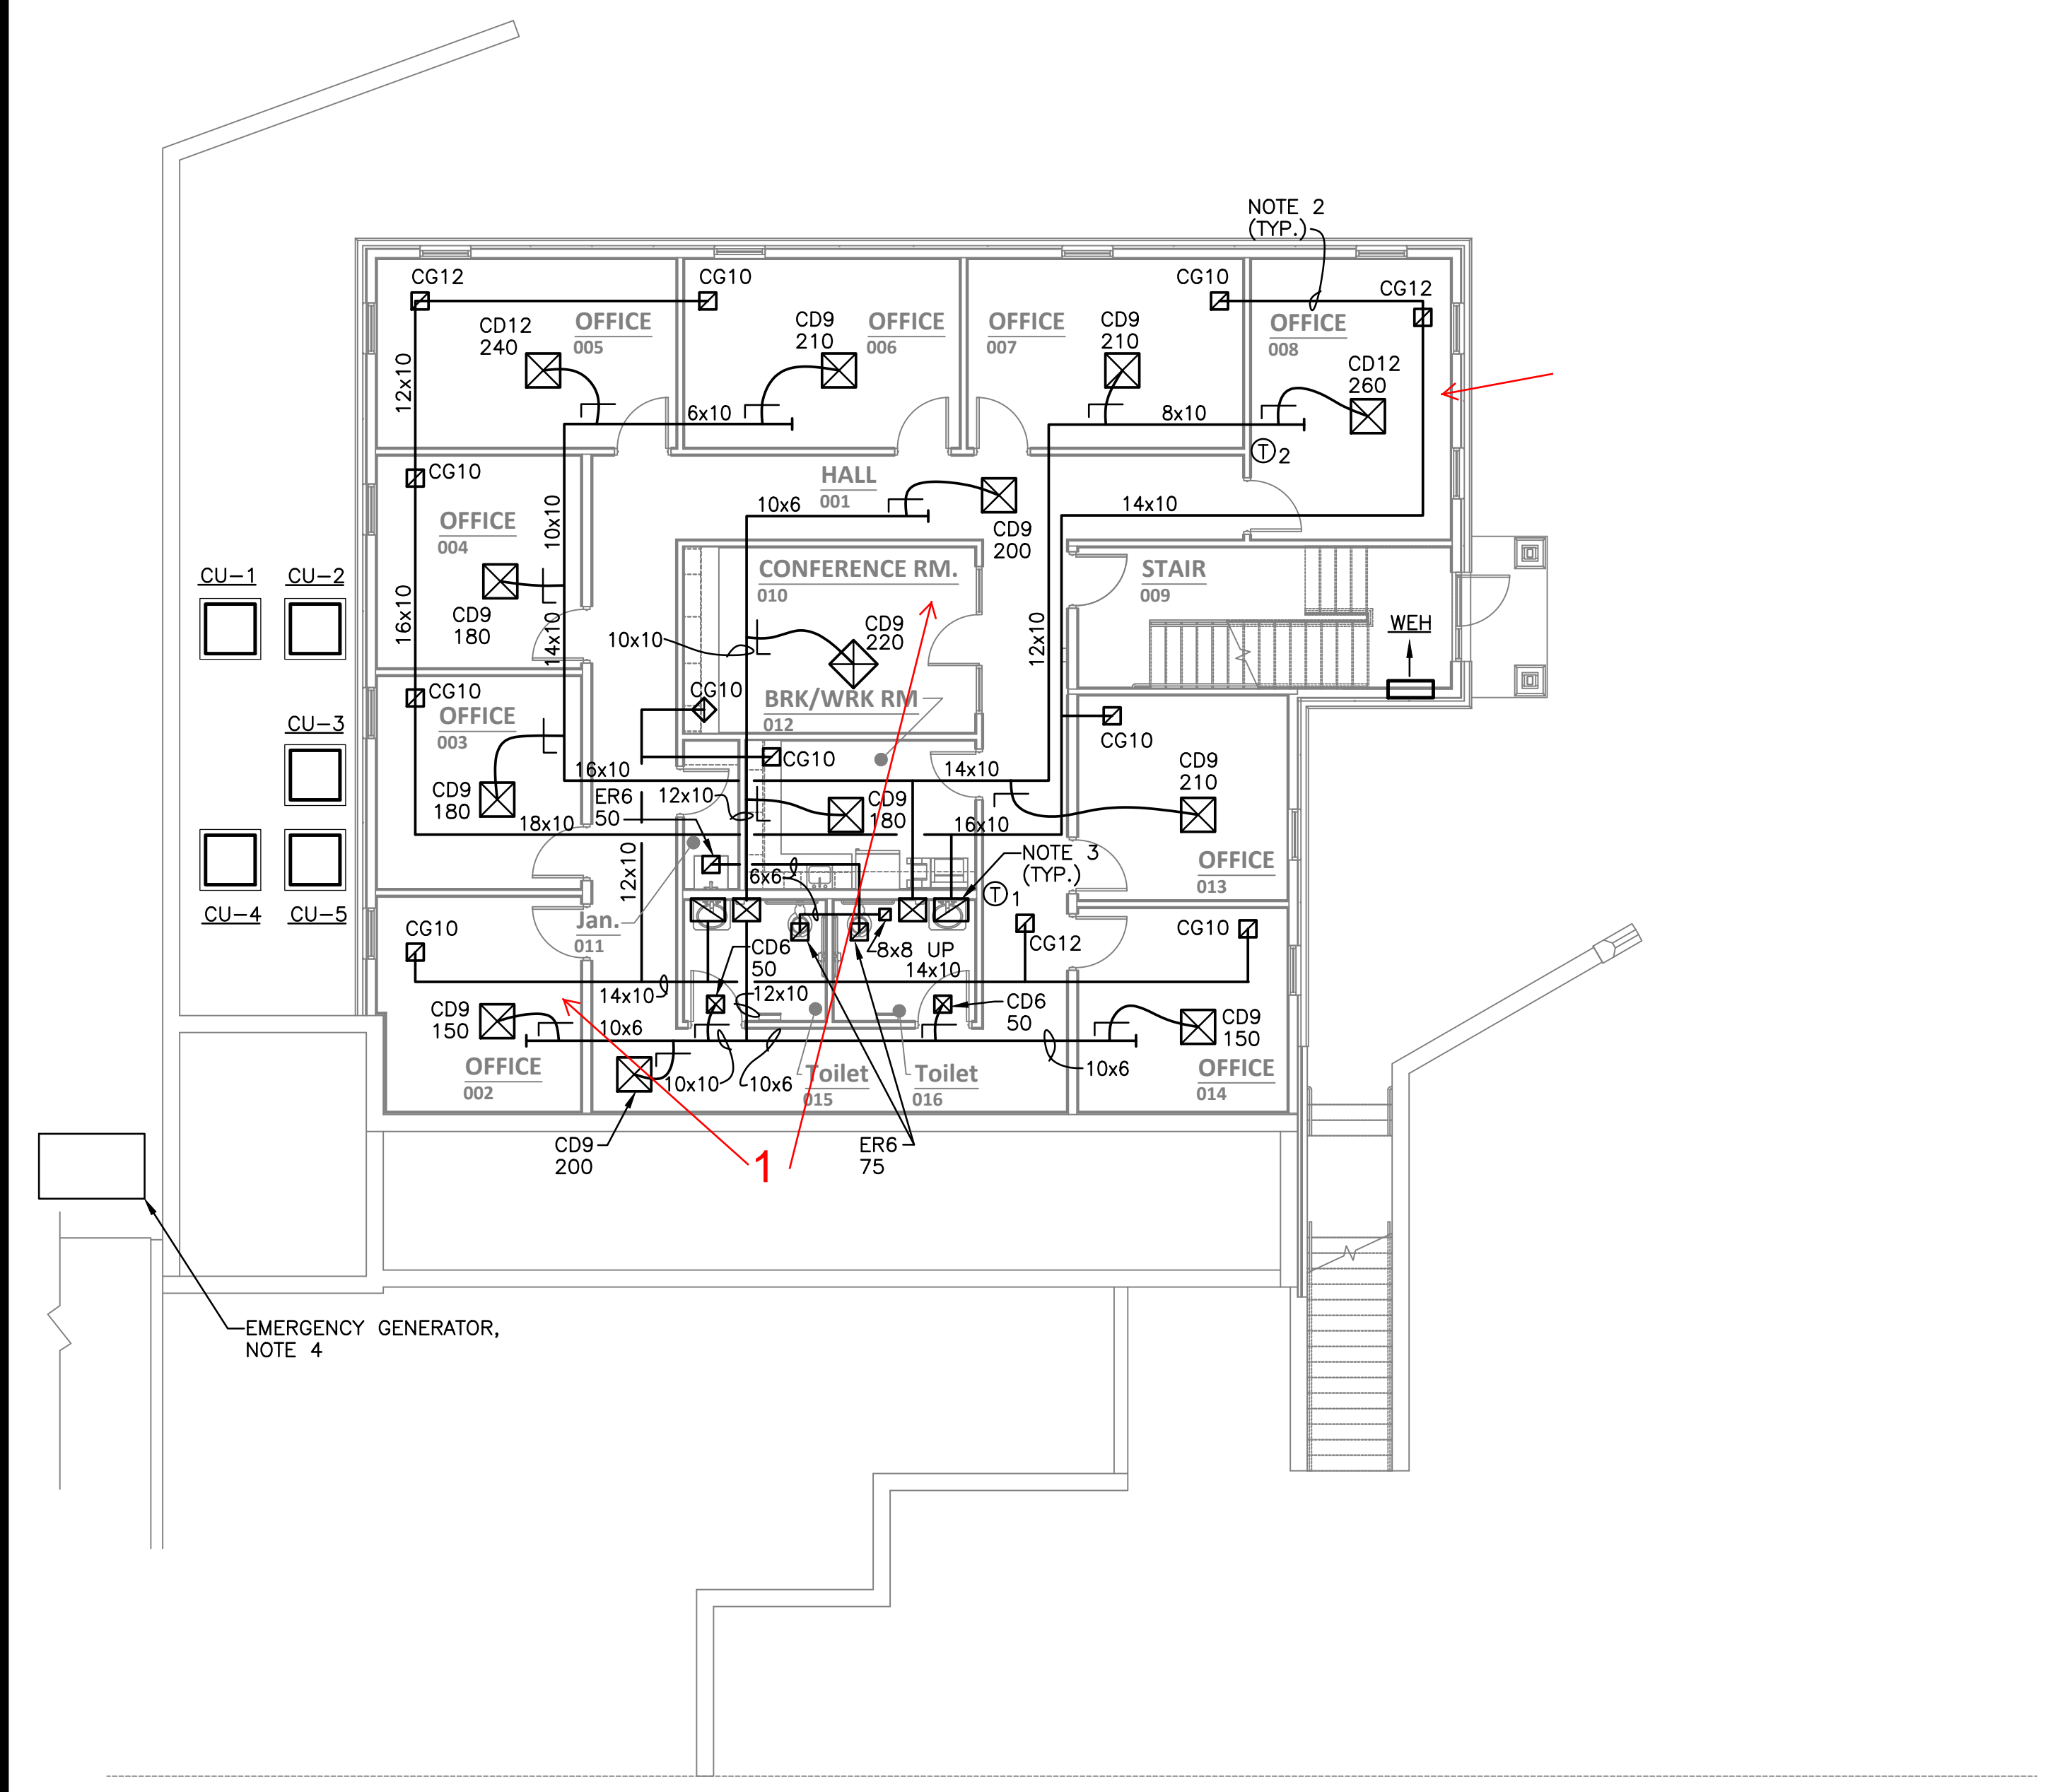

GROUND FLOOR PLAN
 - MECHANICAL NEW WORK
 SCALE: 1/8"=1'-0"

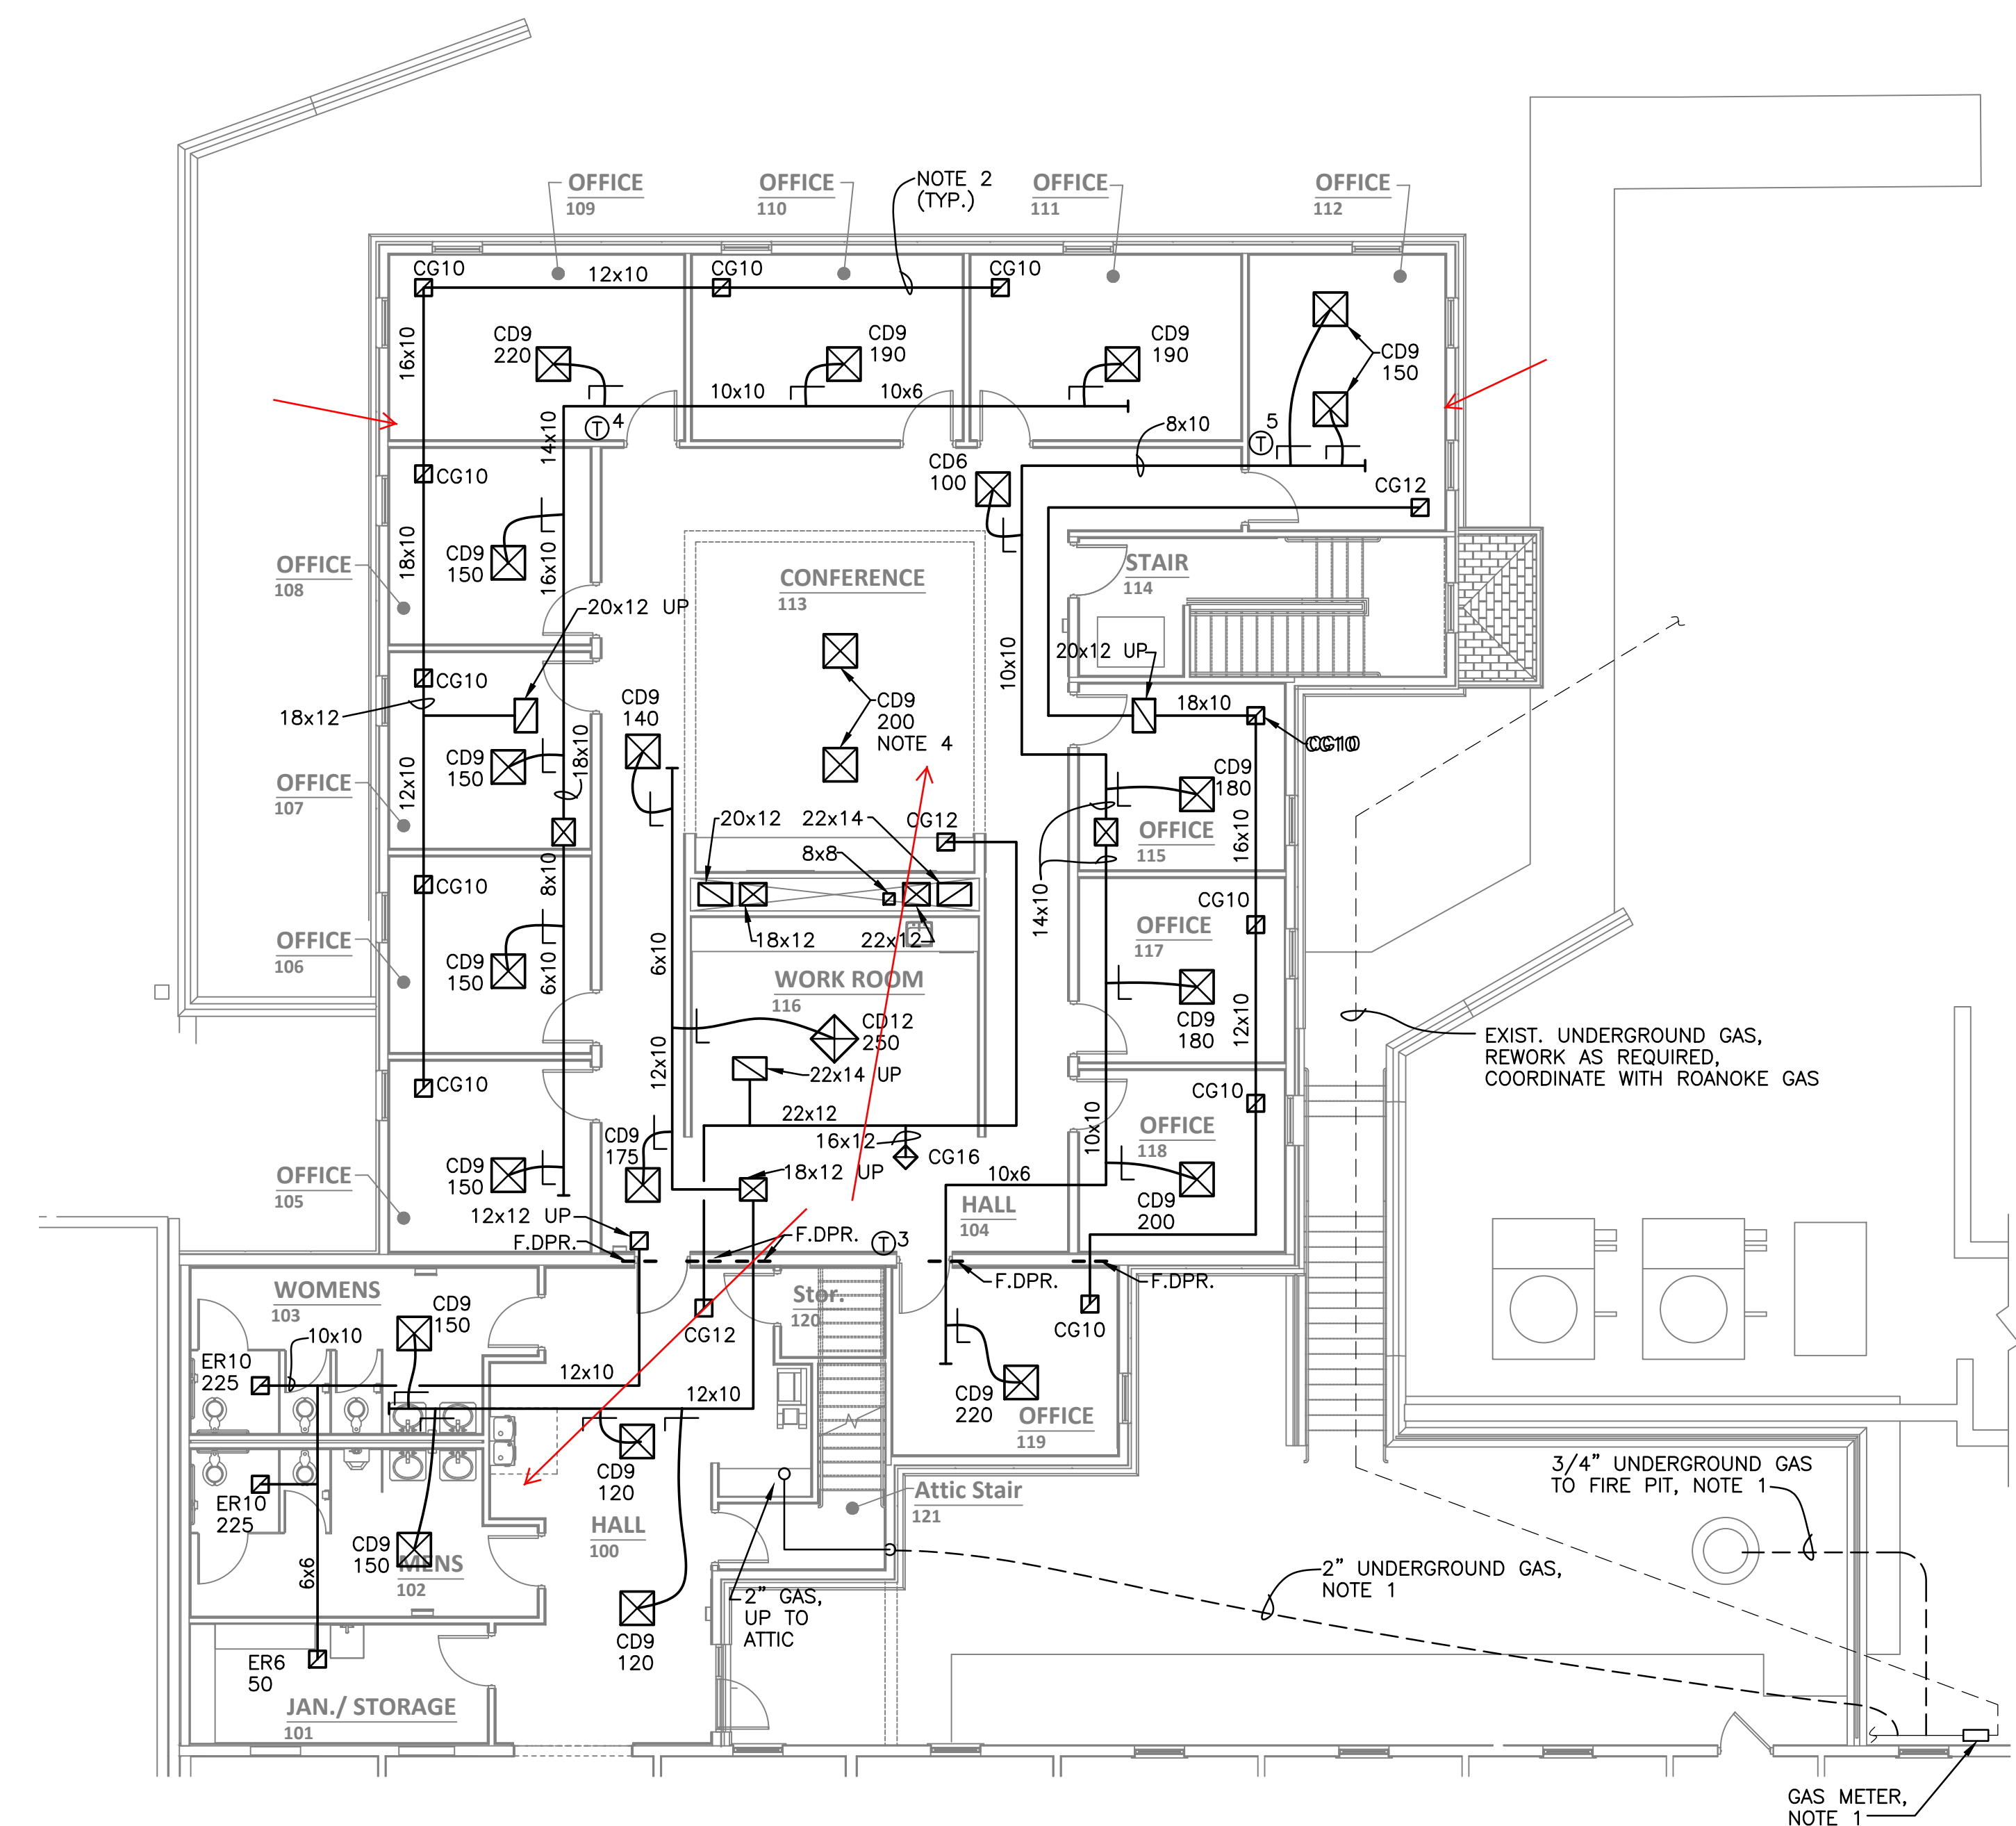

FIRST FLOOR PLAN
 - MECHANICAL NEW WORK
 SCALE: 1/8"=1'-0"

NOTES THIS SHEET

1. SEE 'GAS RISER DIAGRAM' ON SHEET M2-1.
2. RETURN DUCT SIZE TO MATCH CEILING RETURN GRILLE (10X10 DUCT FOR CG10 GRILLE), UNLESS NOTED OTHERWISE.
3. SEE FIRST FLOOR PLAN AND MECHANICAL ATTIC PLAN FOR DUCT SIZES DOWN THROUGH CHASE. PROVIDE FIRE DAMPERS WHERE EACH DUCT ENTERS AND EXITS THE CHASE.
4. EXTEND GAS PIPING TO RELOCATED EMERGENCY GENERATOR AND RECONNECT.